


FAST AND ACCURATE
 JUNE 19, 2023
 REGISTERED PROFESSIONAL ENGINEER
 MEP GREEN DESIGN & BUILD, P.L.C.
 REGISTRATION # F-10982
 915 GDMN ST, HOUSTON, TX 77028
 TEL: (281)-785-1155
 FAX: (281)-282-9144
 WWW.MEPGREENDESIGNS.COM

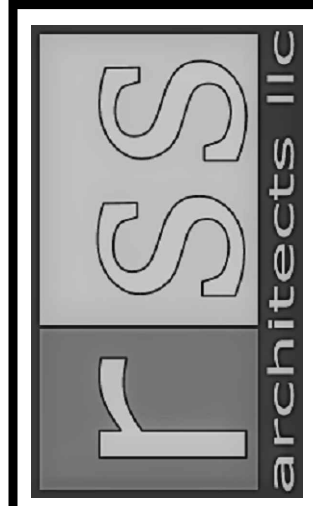


RSS-ARCHITECTS.COM
 817/538-9258

Date 06-19-2023

Job 19060

Sheet

FA2.2

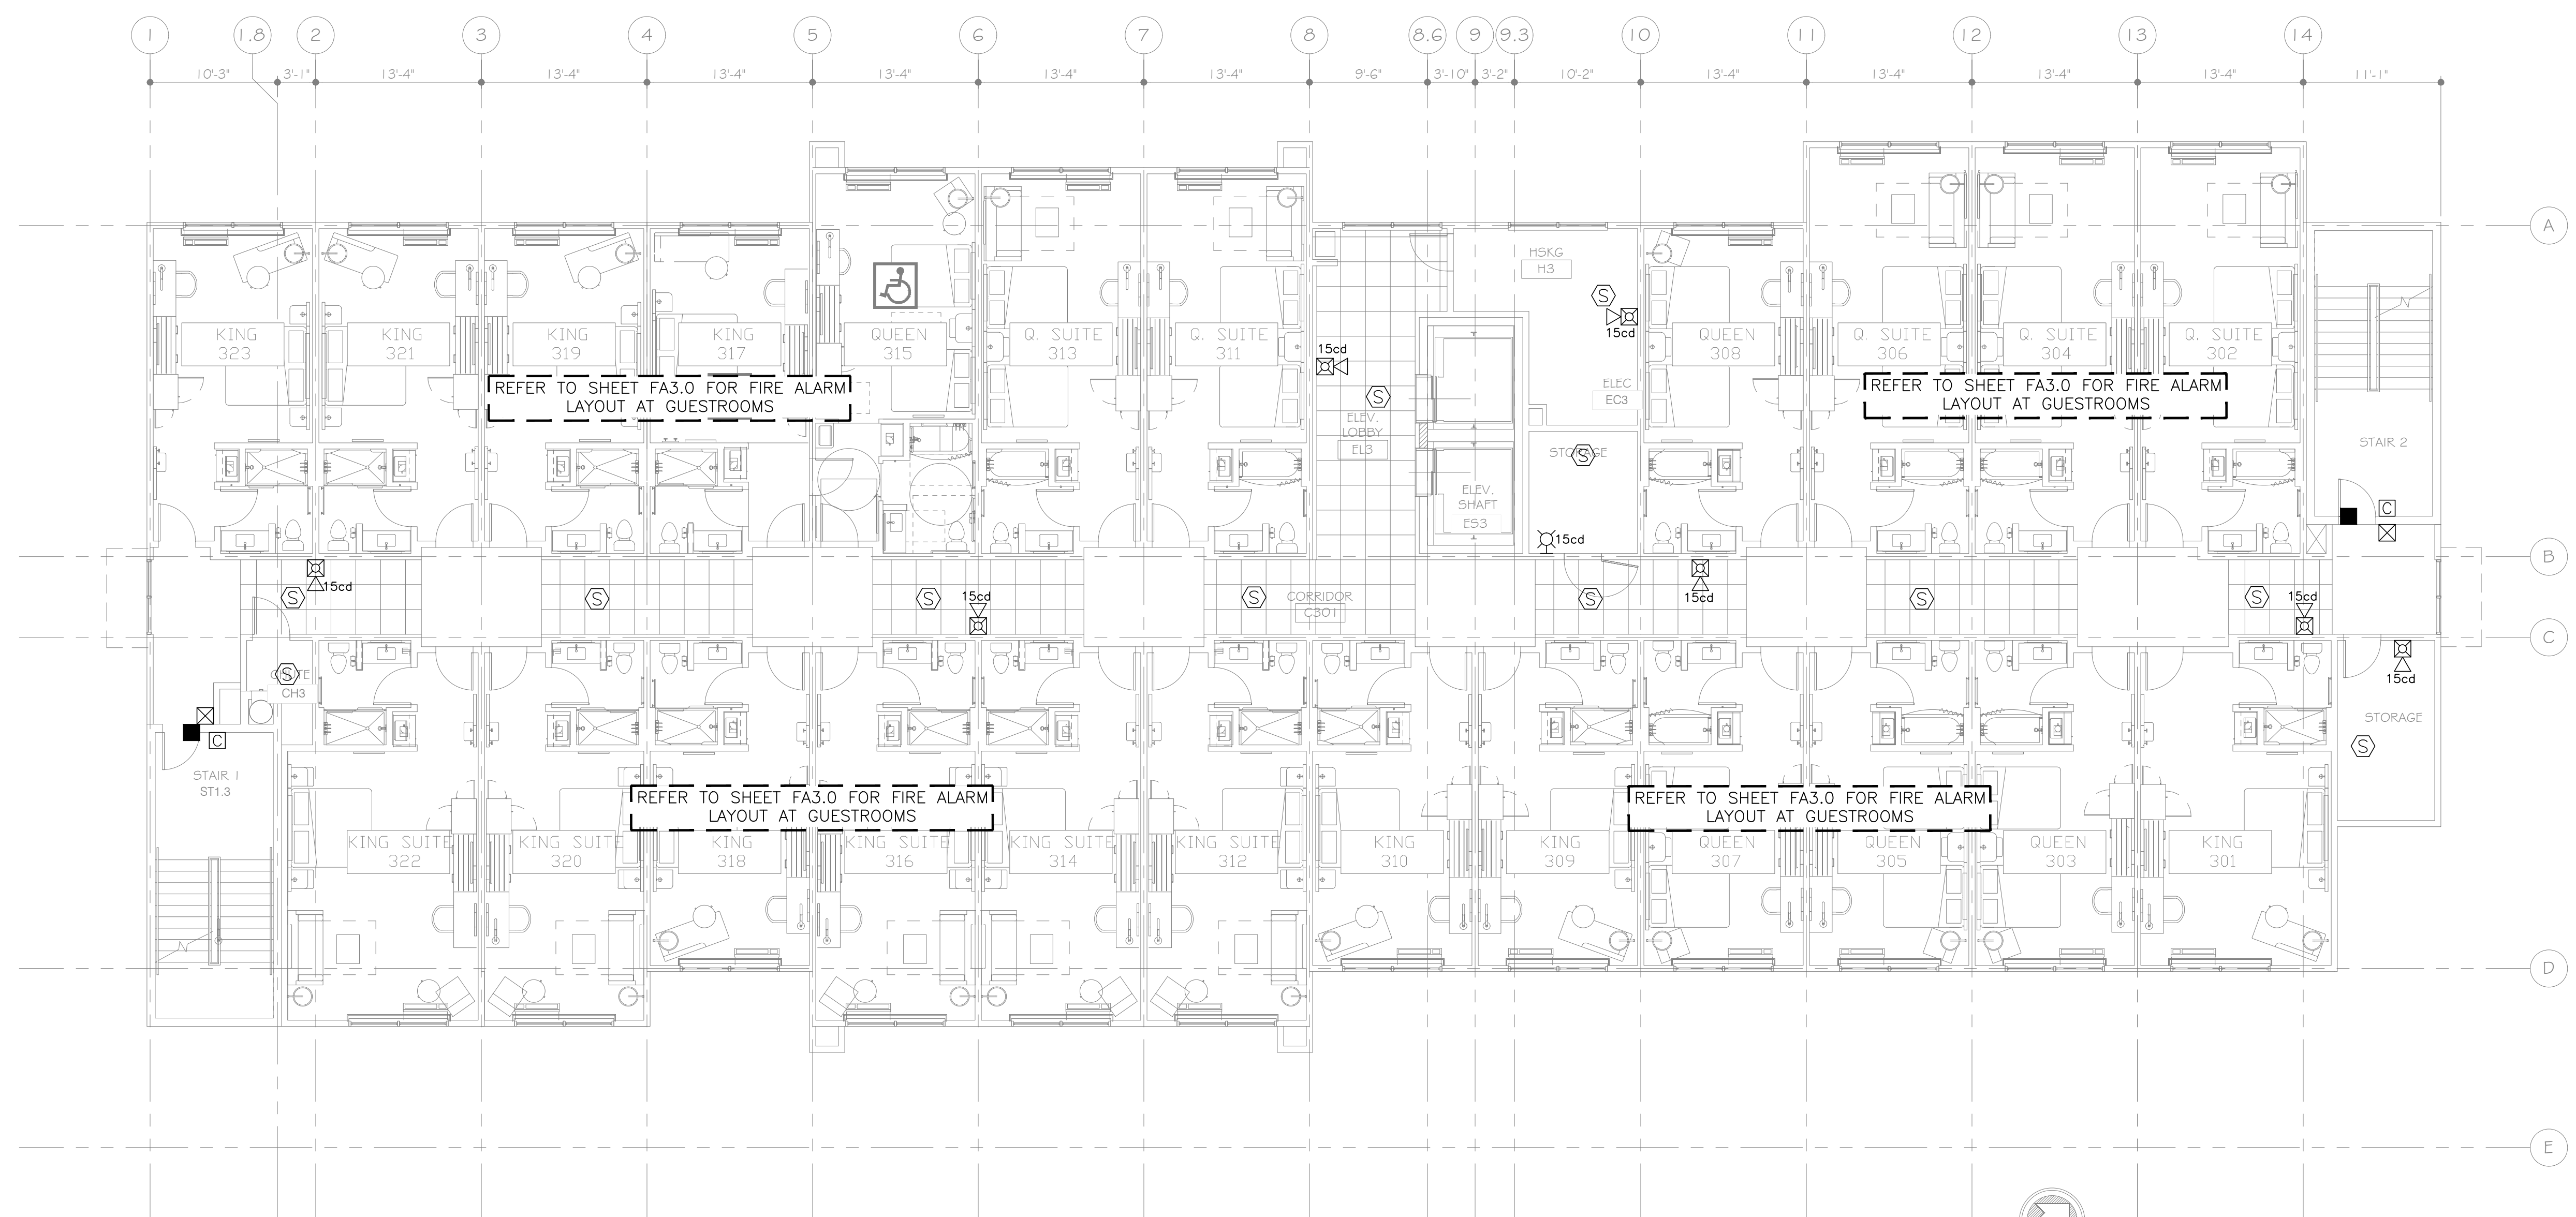

1 FIRE ALARM THIRD FLOOR PLAN
 SCALE: 1/8"=1'-0"

FIRE ALARM SYMBOL LIST		
SYMB.	DESCRIPTION	MOUNTING OR AS INDICATED
⊠	FIRE ALARM MANUAL PULL STATION	WALL - 48" AFF
⊠	ANNUNCIATOR AUDIO/VISUAL	WALL - 6'-8" AFF
⊠	COMBINATION HORN/STROBE LIGHT	WALL - 6'-8" AFF
⊠	STROBE LIGHT	WALL - 6'-8" AFF
⊠	FIRE BELL	WALL
⊠	SMOKE DETECTOR	CEILING
⊠	DUCT DETECTOR	IN MECH. DUCT
⊠	HEAT DETECTOR	CEILING
■	MAGNETIC DOOR HOLDER	WALL
□	SPECIAL DEVICE (AS NOTED)	
⊠	SHUT DOWN RELAY	
⊠	FLOW SWITCH (SPRINKLER)	
⊠	TAMPER SWITCH (SPRINKLER)	
⊠	SMOKE DETECTOR	WALL
⊠	CARBON MONOXIDE DETECTOR	
⊠	FIREMAN'S PHONE	WALL - 48" AFF.
⊠	2-WAY COMMUNICATION DEVICE	WALL - 48" AFF.
⊠	ANNUNCIATOR PANEL	
⊠	FIRE ALARM CONTROL PANEL (FACP)	
♿	INDICATES HANDICAP ACCESS SUITE	
♿	INDICATES HEARING IMPAIRED SUITE	

NOTE FOR FIRE ALARM SYSTEM:

- FIRE ALARM SYSTEM SHALL BE SEPARATELY PERMITTED AND SUBMITTED BY THE FIRE ALARM CONTRACTOR.

MEP GREEN DESIGN & BUILD, P.L.C. RETAINS COPYRIGHT TO THIS DOCUMENT. THE IDEA DESIGN AND DETAILS, AS A PROFESSIONAL AND INTELLECTUAL INSTRUMENT OF SERVICE, AND IS NOT TO BE USED/COPIED IN WHOLE OR IN PART, FOR ANY OTHER PROJECT WITHOUT THE EXPRESSED WRITTEN CONSENT OF MEP GREEN DESIGN & BUILD, P.L.C.