


RSS-ARCHITECTS.COM
817/538-9258

Date 06-19-2023

Job 19060

Sheet

P2.0

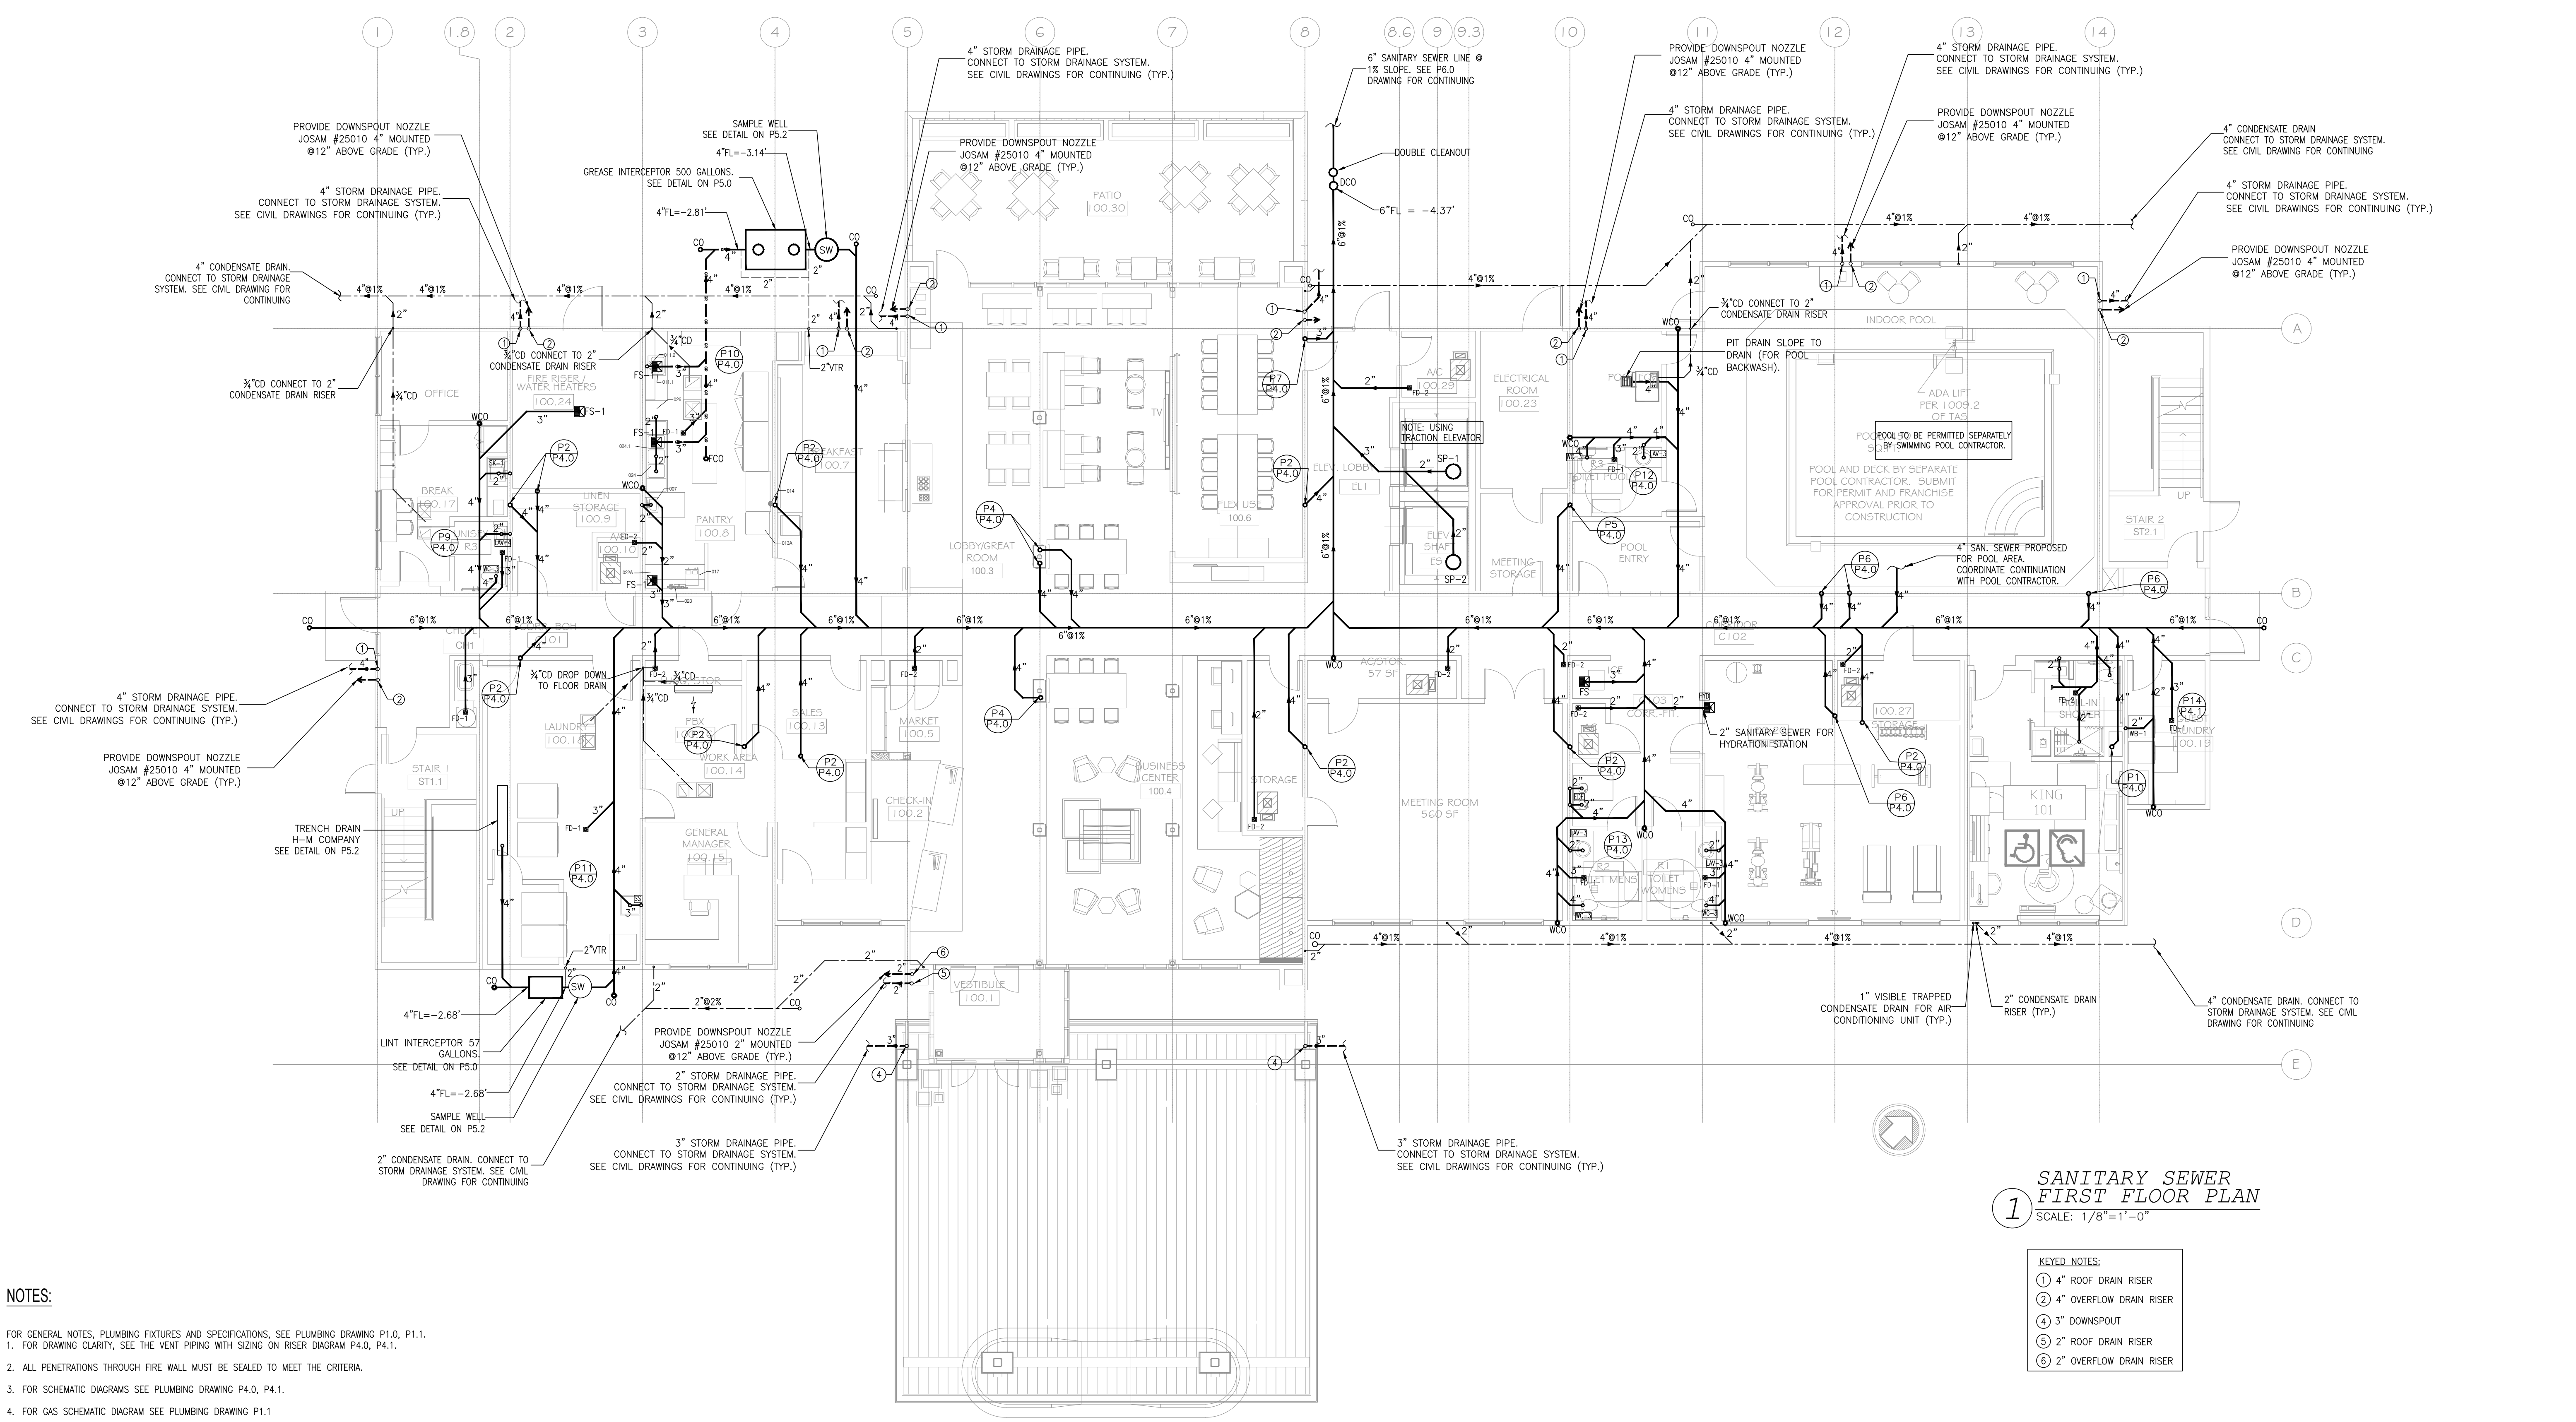

1 SANITARY SEWER FIRST FLOOR PLAN
SCALE: 1/8"=1'-0"

- KEYED NOTES:**
- ① 4" ROOF DRAIN RISER
 - ② 4" OVERFLOW DRAIN RISER
 - ③ 3" DOWNSPOUT
 - ④ 2" ROOF DRAIN RISER
 - ⑤ 2" OVERFLOW DRAIN RISER

- NOTES:**
- FOR GENERAL NOTES, PLUMBING FIXTURES AND SPECIFICATIONS, SEE PLUMBING DRAWING P1.0, P1.1.
 1. FOR DRAWING CLARITY, SEE THE VENT PIPING WITH SIZING ON RISER DIAGRAM P4.0, P4.1.
 2. ALL PENETRATIONS THROUGH FIRE WALL MUST BE SEALED TO MEET THE CRITERIA.
 3. FOR SCHEMATIC DIAGRAMS SEE PLUMBING DRAWING P4.0, P4.1.
 4. FOR GAS SCHEMATIC DIAGRAM SEE PLUMBING DRAWING P1.1
 5. ALL FLOOR DRAINS TO BE INSTALLED W/TRAP PRIMERS.
 6. PROVIDE DRAIN & VENT FOR SWIMMING POOL PER RECOMMENDATION OF POOL EQUIPMENT SUPPLIER.
 7. CONTRACTOR TO SUPPLY THE TEMPERED WATER LIMITING DEVICE FOR WATER HEATER SYSTEM
 8. VACUUM RELIEF VALVE INSTALLED IN THE COLD WATER SUPPLY LINE ABOVE THE TOP OF THE HEATER OR TANK, SHALL BE PROVIDED TO PREVENT SIPHONING OF ANY STORAGE WATER HEATER OR TANK.
 9. DRAIN SIZES FROM PLUMBING FIXTURES SHALL BE AS FOLLOWS:
WATER CLOSETS- 4"
BATHTUB - 2"
LAVATORY - 2"
FLOOR DRAIN (GUESTROOM)- 2"
FLOOR DRAIN (PUBLIC AREAS) - 3"
FLOOR SINK - 3"

1. THE PLUMBING CONTRACTOR MUST PREPARE SHOP DRAWING TO COORDINATE WITH STRUCTURAL ENGINEER BEFORE INSTALLING AND GUARANTEE THE WATER, SEWER AND STORM LINE DO NOT RUNNING ALONG WITH THE GRADE BEAMS.

2. THE CONTRACTOR MUST PERFORM THE COLD/HOT WATER BALANCING TO ENSURE SUFFICIENT HOT WATER THAT DELIVERS TO EVERY GUESTROOM UNIT BEFORE CEILING TILE IS INSTALLED

EQUIPMENT SCHEDULE												
ITEM NO	QTY	EQUIPMENT CATEGORY	EQUIPMENT REMARKS	COLD WATER SIZE (IN)	COLD WATER AFF (IN)	HOT WATER SIZE (IN)	HOT WATER AFF (IN)	DIRECT DRAIN SIZE (IN)	DIRECT DRAIN AFF (IN)	INDIR DRAIN SIZE (IN)	PLUMBING REMARKS	COMMENTS
007	1	HAND SINK	SOAP & TOWEL DISPENSER BY VENDOR	1/2	12	1/2	12	1 1/2	24	1 1/2		
011.1	1	SINK WELDED INTO TABLE	FURNISH W/ BASKET DRAIN									
011.2	1	FAUCET		1/2	12	1/2	12					
013A	1	COMBI OVEN-STEAMER	W/ EQUIPMENT STAND	1/2	*						*FROM FILTER ITEM #014	SEE MFR. INFO. FOR HIGH TEMP. PIPING NEEDS
014	1	FILTER SYSTEM		1/2	24							
017	1	COFFEE BREWER	BY VENDOR	1/4	*						*FROM FILTER ITEM #023	
022A	1	ICE (BASE)	FULL TABLE	3/8	*					3/4	*FROM FILTER ITEM #023	
023	1	FILTER SYSTEM	FOR ICE MAKER & COFFEE BREWER	3/4	48							
024	1	THREE COMPARTMENT SINK	FURNISH W/ BASKET DRAINS							(3) 1 1/2		
024.1	1	FAUCET AND PRE-RINSE		1/2		1/2						
026	1	UNDERCOUNTER WAREWASHER		1/2		3/4	12			1		

MEP GREEN DESIGN & BUILD, P.L.L.C. RETAINS COPYRIGHT TO THIS DOCUMENT. THE IDEA DESIGN AND DETAILS ARE A PROFESSIONAL AND INTELLECTUAL INSTRUMENT OF SERVICE AND IS NOT TO BE USED/COPIED IN WHOLE OR IN PART, FOR ANY OTHER PROJECT WITHOUT THE EXPRESSED WRITTEN CONSENT OF MEP GREEN DESIGN & BUILD, P.L.L.C.